


33 32 31 30 29 28 27 26 25 24 23 22 21 20 19 18 17 16 15 14 13 12 11 10 9 8 7 6 5 4 3 2 1 0

2018 195.8 189.6 183.6 177.4 171.4 165.2 159.2 153.1 146.9 140.8 134.8 128.6 122.6 116.4 110.3 104.2 98.1 92.1 85.9 79.8 73.7 67.6 61.4 55.3 49.3 43.1 37.0 30.9 24.8 18.7 12.6 6.5 0(m)

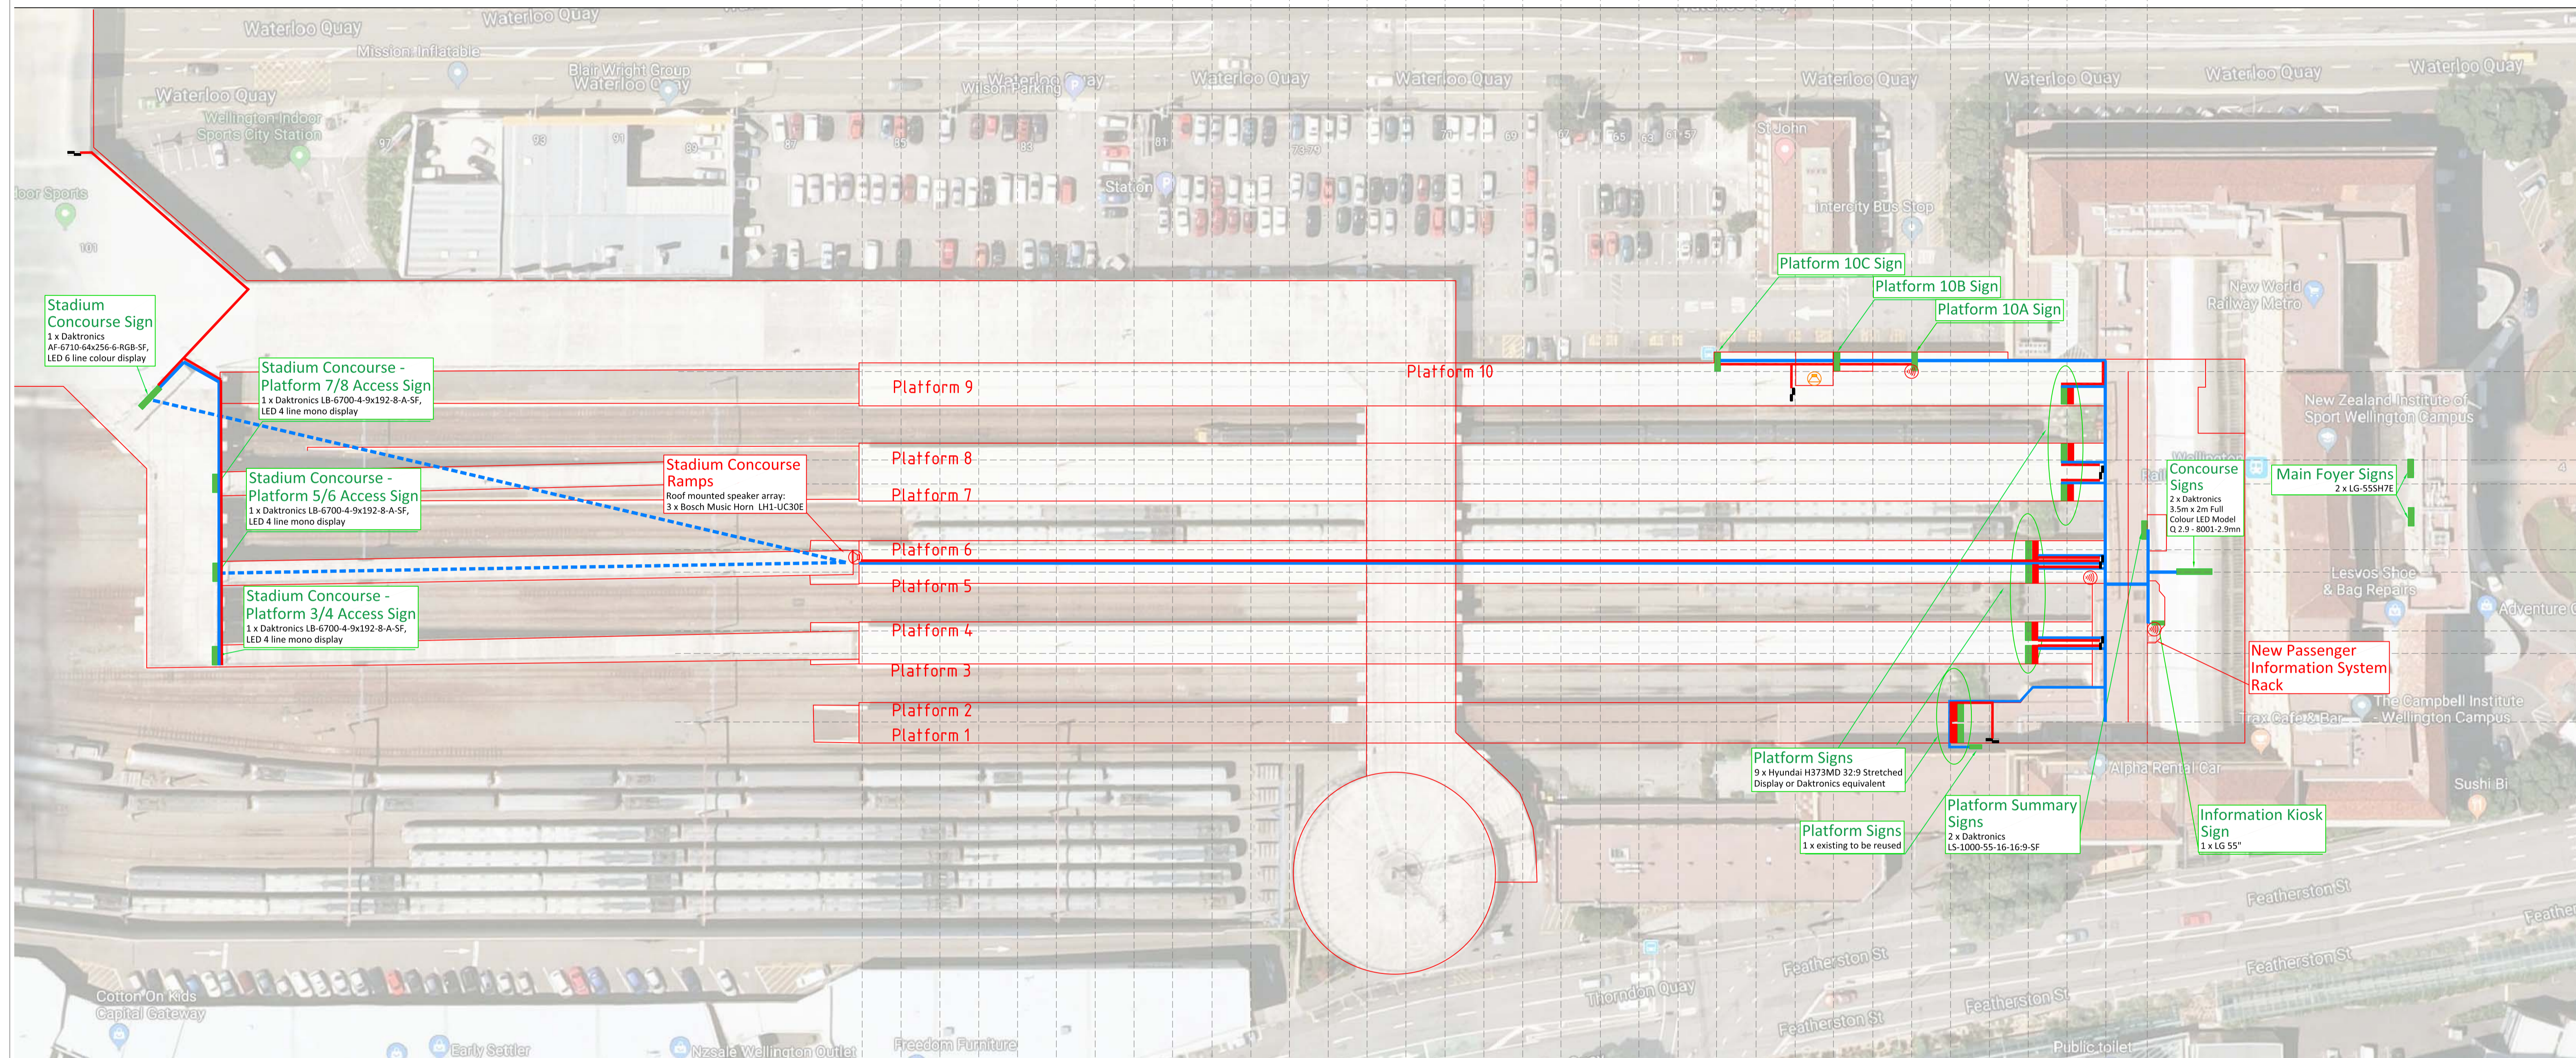

33 32 31 30 29 28 27 26 25 24 23 22 21 20 19 18 17 16 15 14 13 12 11 10 9 8 7 6 5 4 3 2 1 0

LEGEND

- ⊕ EXISTING TOA SPEAKERS
- ⊕ NEW BOSCH LBC 3432/03 SPEAKERS
- ⊕ HEARING ASSISTANT ACCESS POINT
- ⊕ SHELTER SPEAKERS
- █ DISPLAY SIGNS
- ⊕ BOSCH MUSIC HORN ARRAY
- NEW DATA CABLE ROUTE - CONDUIT
- WIRELESS DATA CONNECTION
- 84 SPL TEST RESULTS(dB)
- ⊕.47 STI TEST RESULTS

- █ EXISTING ELECTRONIC SIGNS
- EXISTING POWER DISTRIBUTION BOARD
- POWER CABLE ROUTE - CONDUIT

Rev	Revision Description	Drawn	Drawing Checked	Designed	Design Checked	Approved	Date
5							
4							
3							
2							
1							

Scales
NIL
NIL
Original Date 4-Jul-18

BARTONS SOUND SYSTEMS LTD
 PO Box 8821, Symonds Street, Auckland 1150
 info@bartonsound.co.nz Ph. (09) 373 2416
 www.bartonsound.co.nz

This drawing is not to be used for construction purposes unless Status is "Working" and signed and dated

Signed _____ Date _____

WELLINGTON TRAIN STATION		TYPE: PRELIMINARY_SHOP_WORKING_ASBUILT	
CUSTOMER INFORMATION SYSTEM	Level	Status	Rev
		SHOP	2
Drawing No. / Name		PLAN V2 platforms	
Site Plan - Cable Route			

DO NOT SCALE FROM THIS DRAWING